


Updated Substation & Switchyard Layout

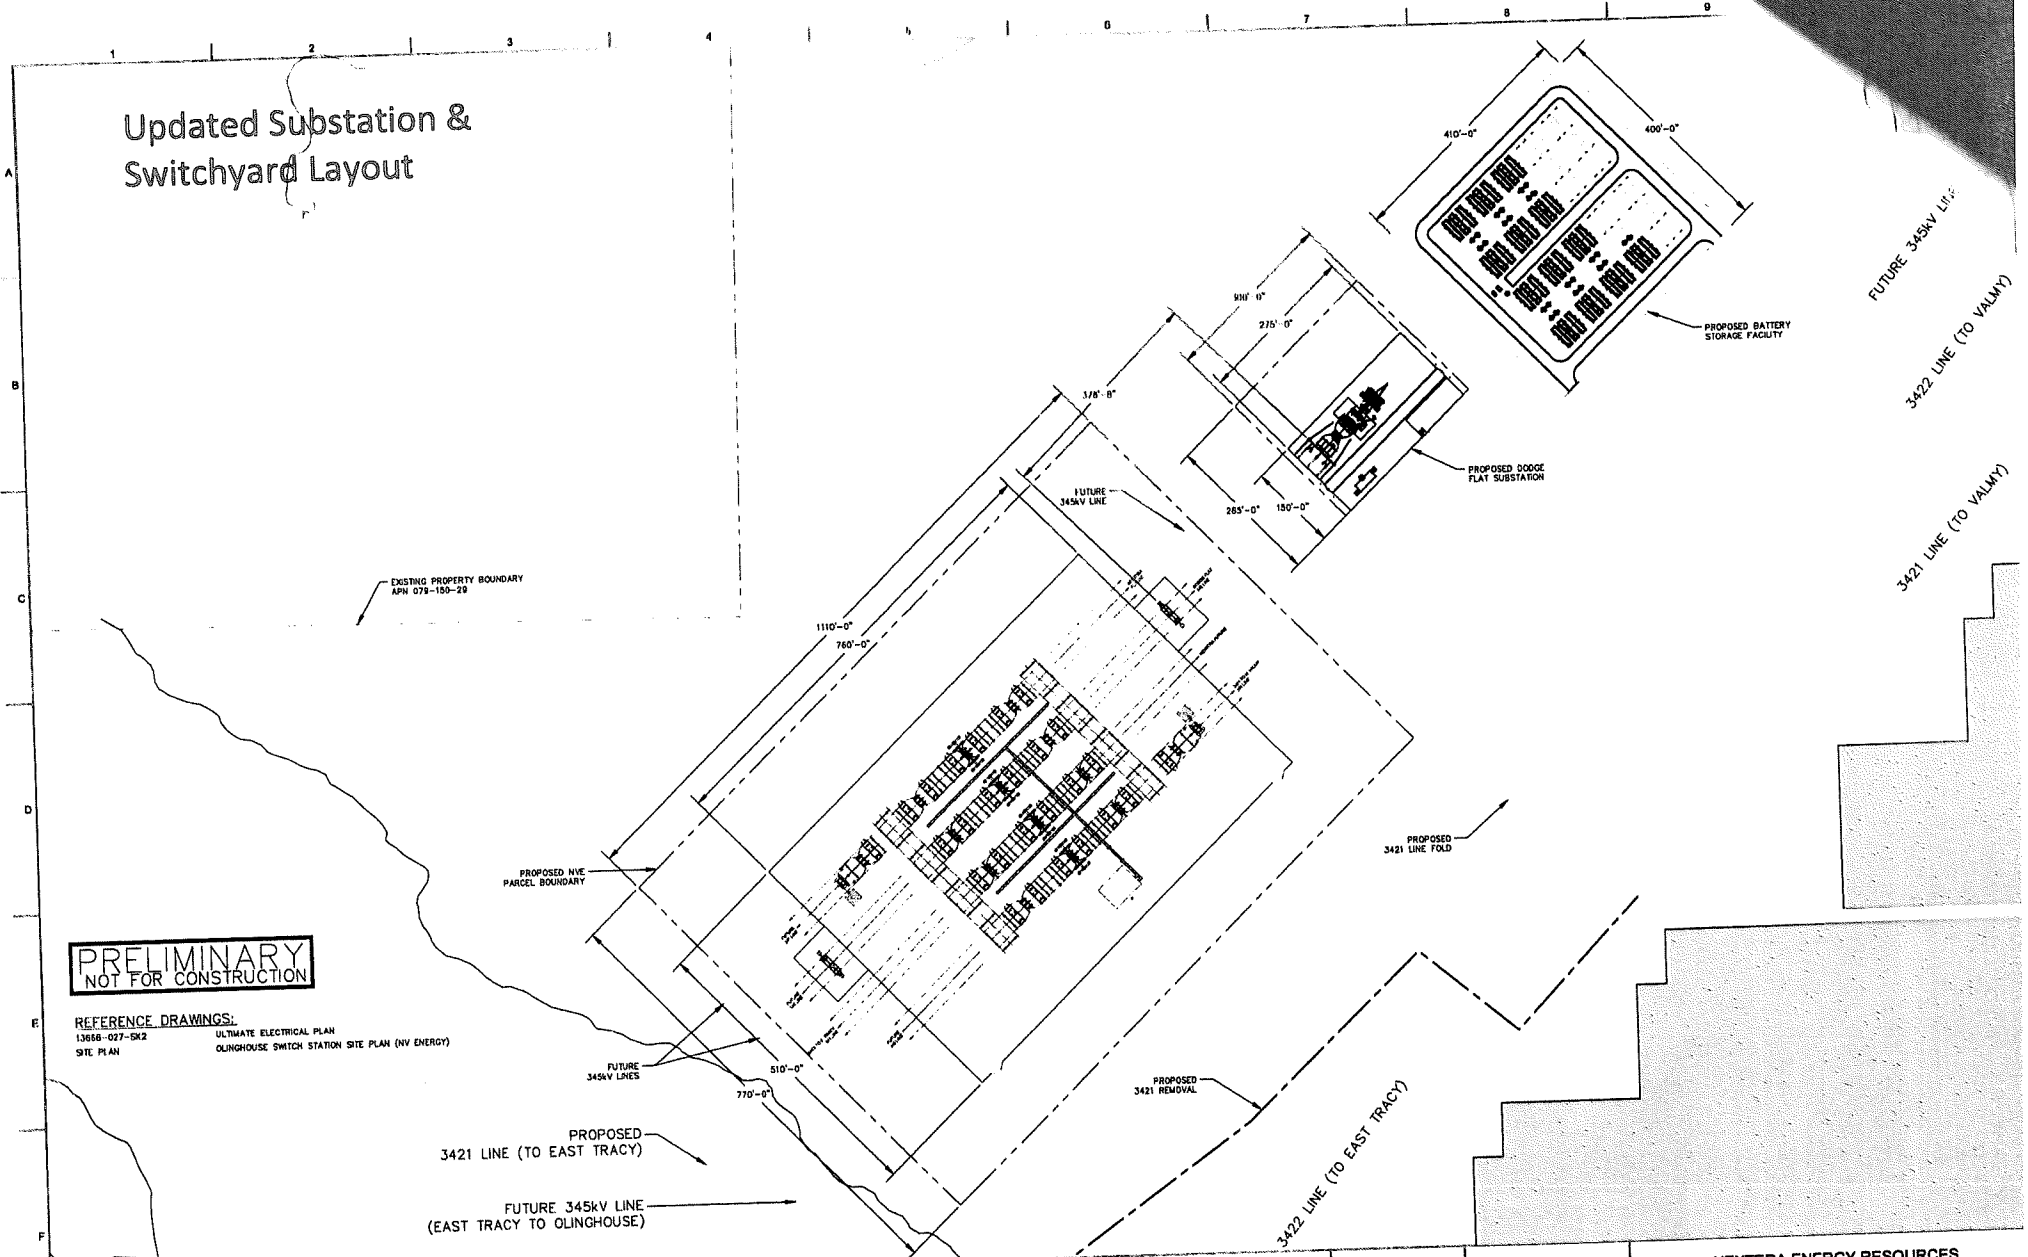

**PRELIMINARY
NOT FOR CONSTRUCTION**

REFERENCE DRAWINGS:
 13686-027-SK2 ULTIMATE ELECTRICAL PLAN
 SITE PLAN OLINGHOUSE SWITCH STATION SITE PLAN (NV ENERGY)

SCALE:
1" = 100'-0"

CONTRACTOR/INSTALLER SHALL TAKE ALL APPROPRIATE PRECAUTIONS TO ENSURE THE SAFETY OF ALL PEOPLE LOCATED ON THE WORK SITE, INCLUDING CONTRACTORS, INSTALLERS PERSONNEL, OR THAT OF ITS SUB-CONTRACTOR(S) PERFORMING THE WORK.

ANY MODIFICATION OR ADDITION TO THIS DRAWING BY ANY ORGANIZATION OTHER THAN BARGENT & LUNDY IS NOT THE RESPONSIBILITY OF BARGENT & LUNDY.

**NEXTERA ENERGY RESOURCES
 DODGE FLAT SOLAR, LLC
 345/34.5 KV COLLECTOR AND 345KV SWITCHING STATION
 SITE ELECTRICAL PLAN**

13686-027-SK1

NO	DATE	REVISIONS AND RECORD OF ISSUE	DRWN	REVD	APPR	COMP	APPD	DATE
B	07/01/2019	ISSUED FOR CONCEPTUAL DESIGN	RJB	FPH	BAL	PREP	RJB	07/01/2019
A	06/02/2019	ISSUED FOR CLIENT COMMENT	RJB	KFB	BAL	PREP	RJB	07/01/2019